


- Notes:
- PROPOSED DUCTING ROUTE 110mm GREEN OR BLACK IN COLOUR
 - PROPOSED DUCT TO FINAL LOCATION 50MM BLACK IN COLOUR
 - JB4 CHAMBER - REFER TO STANDARD DETAIL
 - VM ETU
 - EXISTING CHAMBER
- NOTES**
- DUCTING ROUTES SHOWN ARE INDICATIVE ONLY. THE CONTRACTOR IS FREE TO DECIDE THE MOST APPROPRIATE ROUTE ON SITE. GENERAL PRINCIPLES OF THE DRAWING SHOULD BE ADHERED TO.
 - DUCTING MUST BE BURIED TO REQUIRED DEPTHS DETAILED ON THE DRAWING.
 - SAND AND WARNING MARKER TAPE MUST BE INSTALLED AS DETAILED ON THE DRAWING.
 - THE CONTRACTOR SHALL FINALIZE ALL DUCT WORK DESIGNS WITH THE RELEVANT UTILITY COMPANIES
 - THIS DRAWING IS INDICATIVE FOR PRICING PURPOSES ONLY.
 - JOINING CHAMBERS SHALL BE INSTALLED IN ACCORDANCE WITH VIRGIN MEDIAS BUILDERS SPECIFICATION FOR THEIR COMMS INFRASTRUCTURE REQUIREMENTS. THE CONTRACTOR SHALL FAMILIARIZE THEMSELVES WITH THIS DOCUMENT. THE ENGINEER WILL NOT ENTERTAIN ANY CLAIMS RESULTING FROM THE CONTRACTOR NOT DOING SO
 - ALL MANHOLES AND CHAMBERS TO BE LOCATED, CONSTRUCTED AND INSTALLED IN ACCORDANCE WITH SERVICE PROVIDER STANDARDS. MANHOLES SHALL BE PROVIDED WITH A LOCKING DEVICE WHICH SHALL BE LOCKED AFTER INSTALLATION. RECESSED MANHOLE COVERS TO BE PROVIDED TO HOMEZONE AREA ALLOWING FOR PAVING TO BE LAID IN A REMOVABLE METAL TRAY.

TIE INTO EXISTING SERVICES. EXACT LOCATIONS TO BE CONFIRMED WITH VM

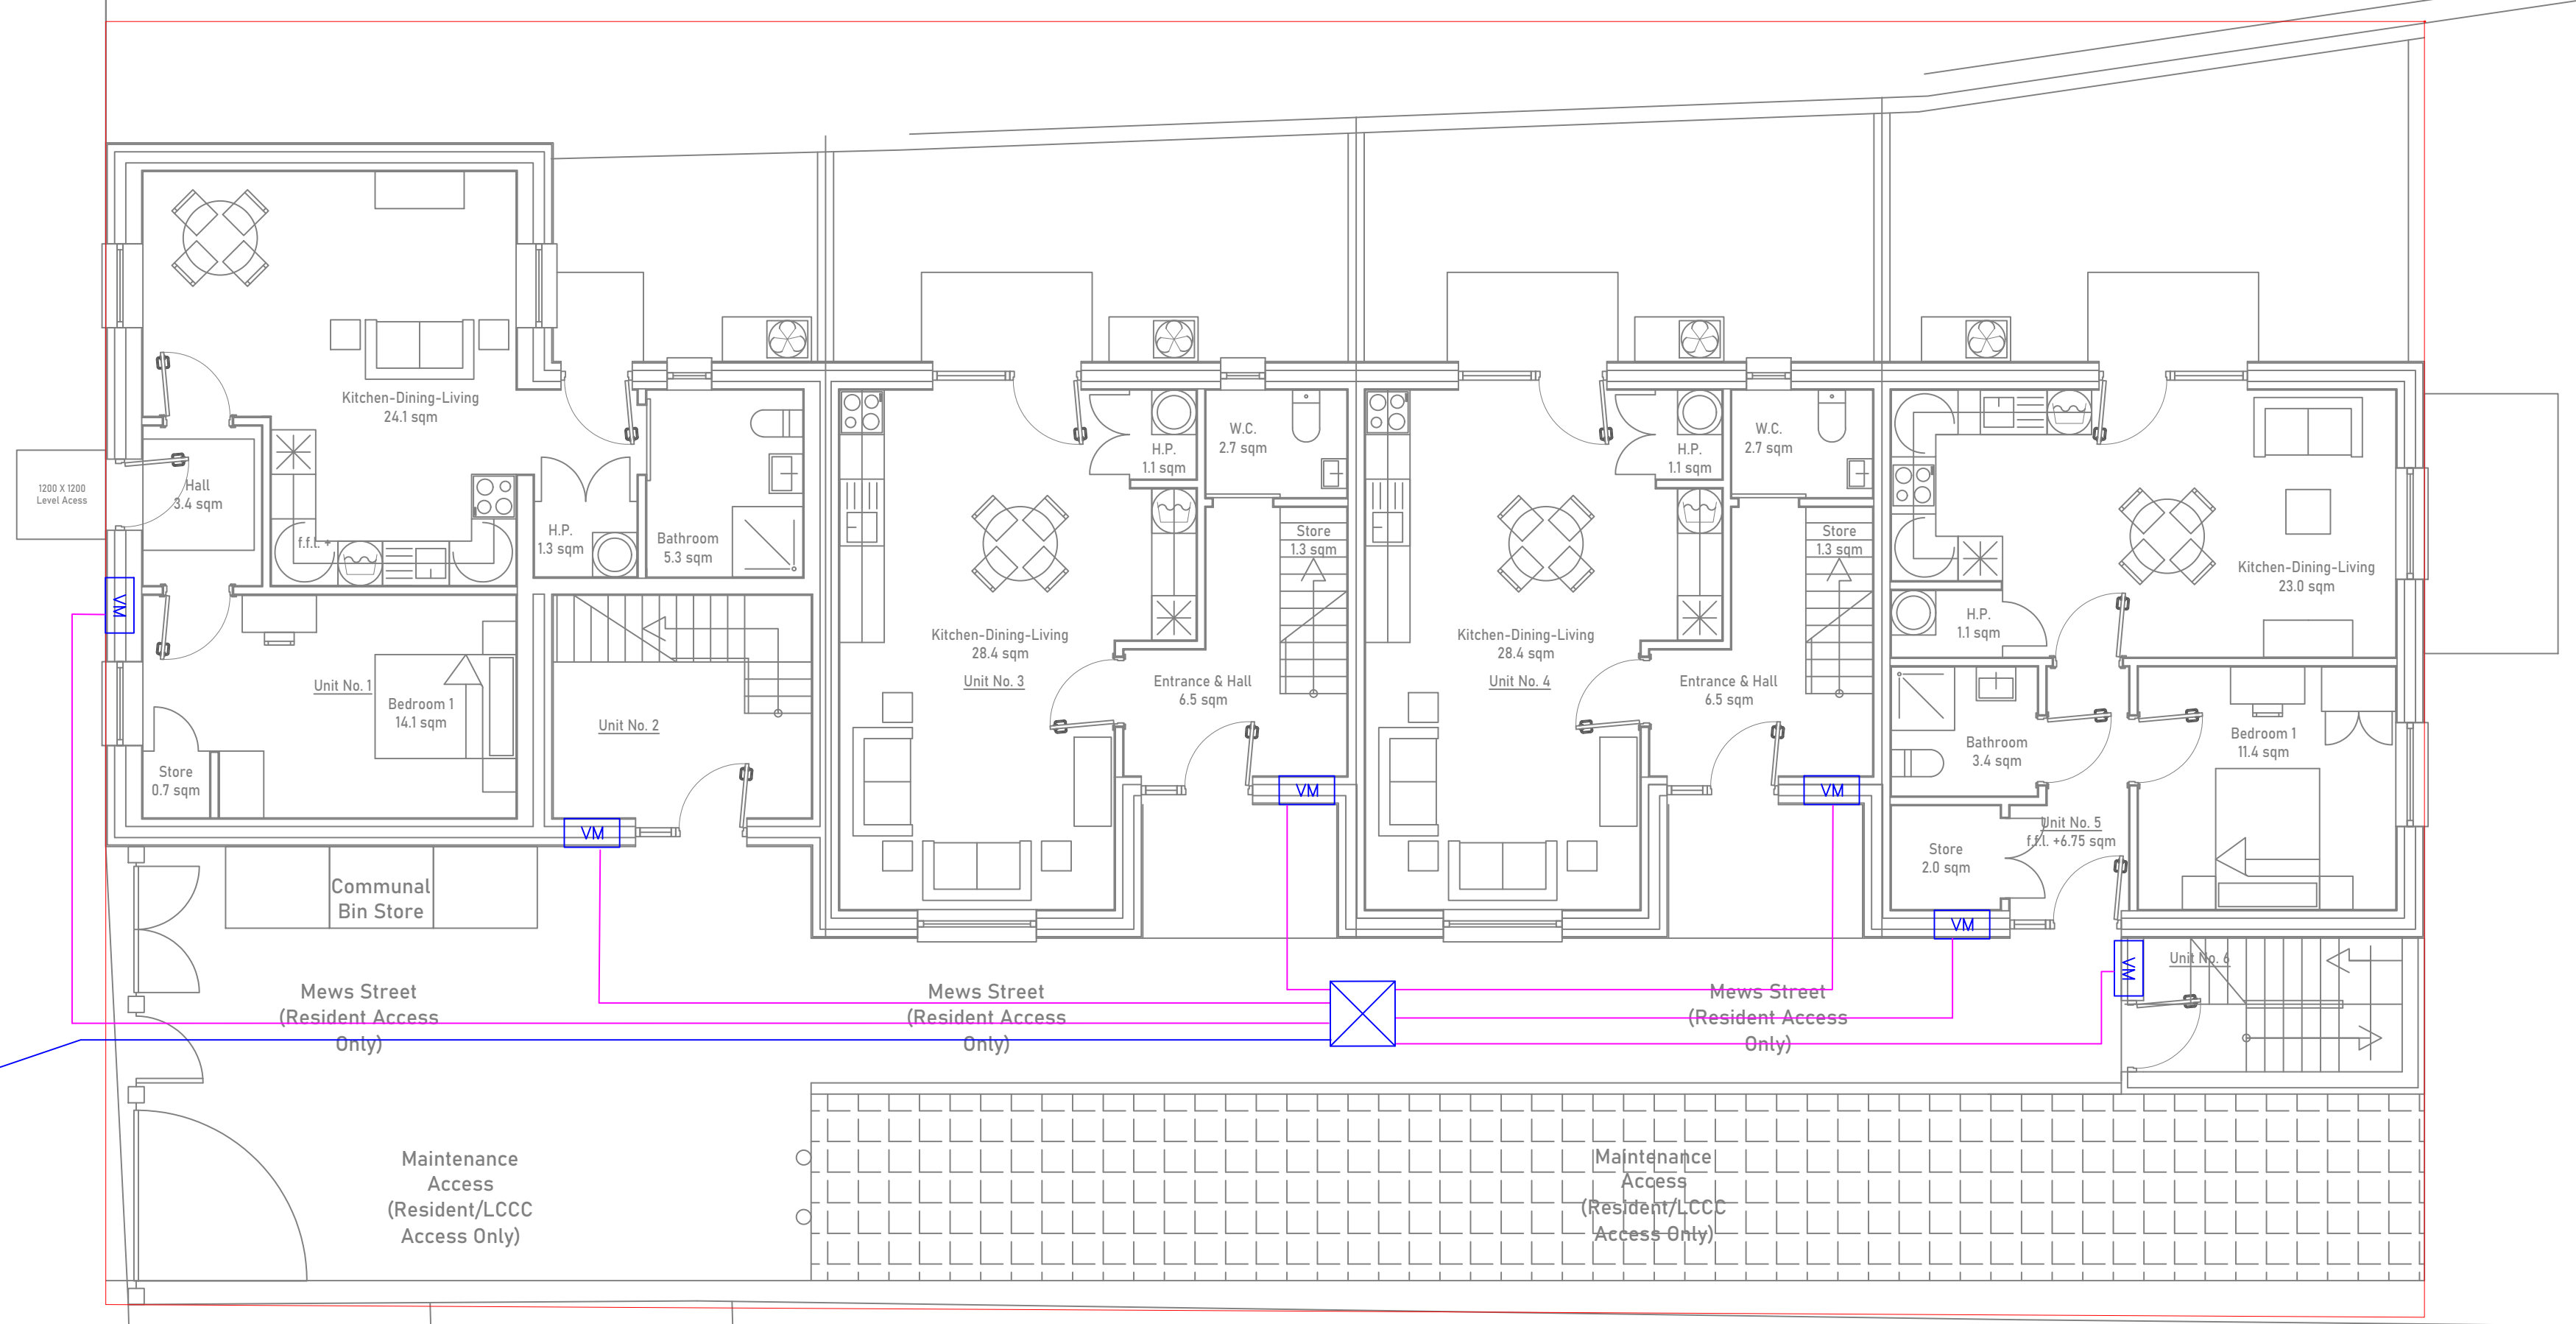


DUCTING IS INDICATIVE FOR PRICING PURPOSES. THE CONTRACTOR SHALL ATTAIN DRAWINGS FROM UTILITY COMPANIES FOR CONSTRUCTION. NOTE, UTILITY COMPANIES ARE RESPONSIBLE FOR THEIR OWN DESIGNS FOR CONSTRUCTION, THE CONTRACTOR MUST LIAISE WITH AND PROCURE A DESIGN FROM THE RELEVANT UTILITY COMPANY

THIS DRAWING IS A SERVICE MARKUP SHOWING SERVICES REQUIREMENTS THIS DRAWING IS NOT A CIVIL ENGINEERING DRAWING. BEST PRACTISE SHALL BE USED TO CARRY OUT THE INSTALLATION. IF IN DOUBT THE CIVIL ENGINEER SHOULD BE CONSULTED.

*****DO NOT USE THIS DRAWING FOR CONSTRUCTION*****

P	Preliminary	RY	05.07.24
REV:	DESCRIPTION:	BY:	DATE:
STATUS:			

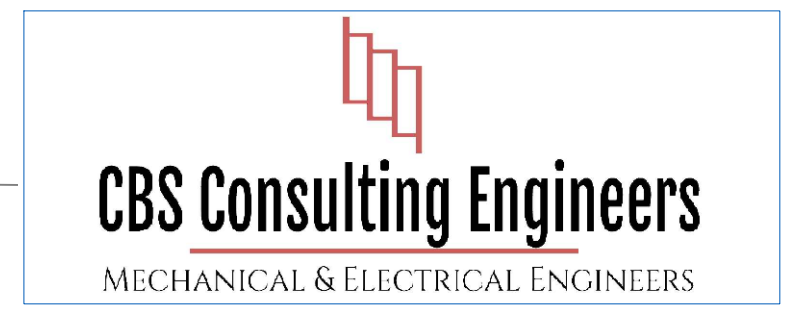

SITE:	52 New Road Thomondgate, Limerick		
TITLE:	Virgin Media Ductwork Layout		
SCALE AT A1:	DATE:	DRAWN:	CHECKED:
1:75	25.06.24	RY	RY
PROJECT NO:	DRAWING NO:	REVISION:	
	E803	P	